


- EXTERIOR FINISH LEGEND:

01. WOOD CLAD WINDOW W/ TRANSOM WINDOW
02. PRECAST STONE
03. MASONRY UNIT (COLOR #1)
04. PRECAST STONE BAND
05. MASONRY UNIT (COLOR #2)
06. METAL BALCONY
07. 4" STONE BAND
08. 4" STONE SILL
09. WOOD CLAD WINDOW
10. SLIDING DOOR W/ TRANSOM WINDOW
11. METAL GUARDRAIL
12. STONE CAP
13. 2" STONE BAND
14. PRECAST 10" + 6" STONE BAND
15. ALUMINUM COPING
16. WOOD CLAD WINDOW (AWNING)
17. ALUMINUM STOREFRONT DOOR
18. NEW WOOD CLAD SLIDER W/ TRANSOM WINDOW
19. NEW STOREFRONT DOOR
20. EXISTING 1 STORY MASONRY BUILDING TO REMAIN
21. BAY WINDOW BEYOND
22. WALL MOUNTED LIGHT FIXTURE
23. CEMENT BOARD PANELING SYSTEM
24. 12" PRECAST STONE HEADER
25. LOUVER FOR EXHAUST FAN (SEE MECHANICAL PLANS FOR DETAILS)
26. INSULATED OVERHEAD GARAGE DOOR
27. 60" ALUMINUM FENCE W/ 3" WIDE GATE
28. CANTILEVERED PREFABRICATED METAL BALCONY
29. CANOPY BY OTHER
30. SIGN - PROVIDE BY OTHER
31. GAS METER BANK
32. 4" HIGH STEEL BOLLARD

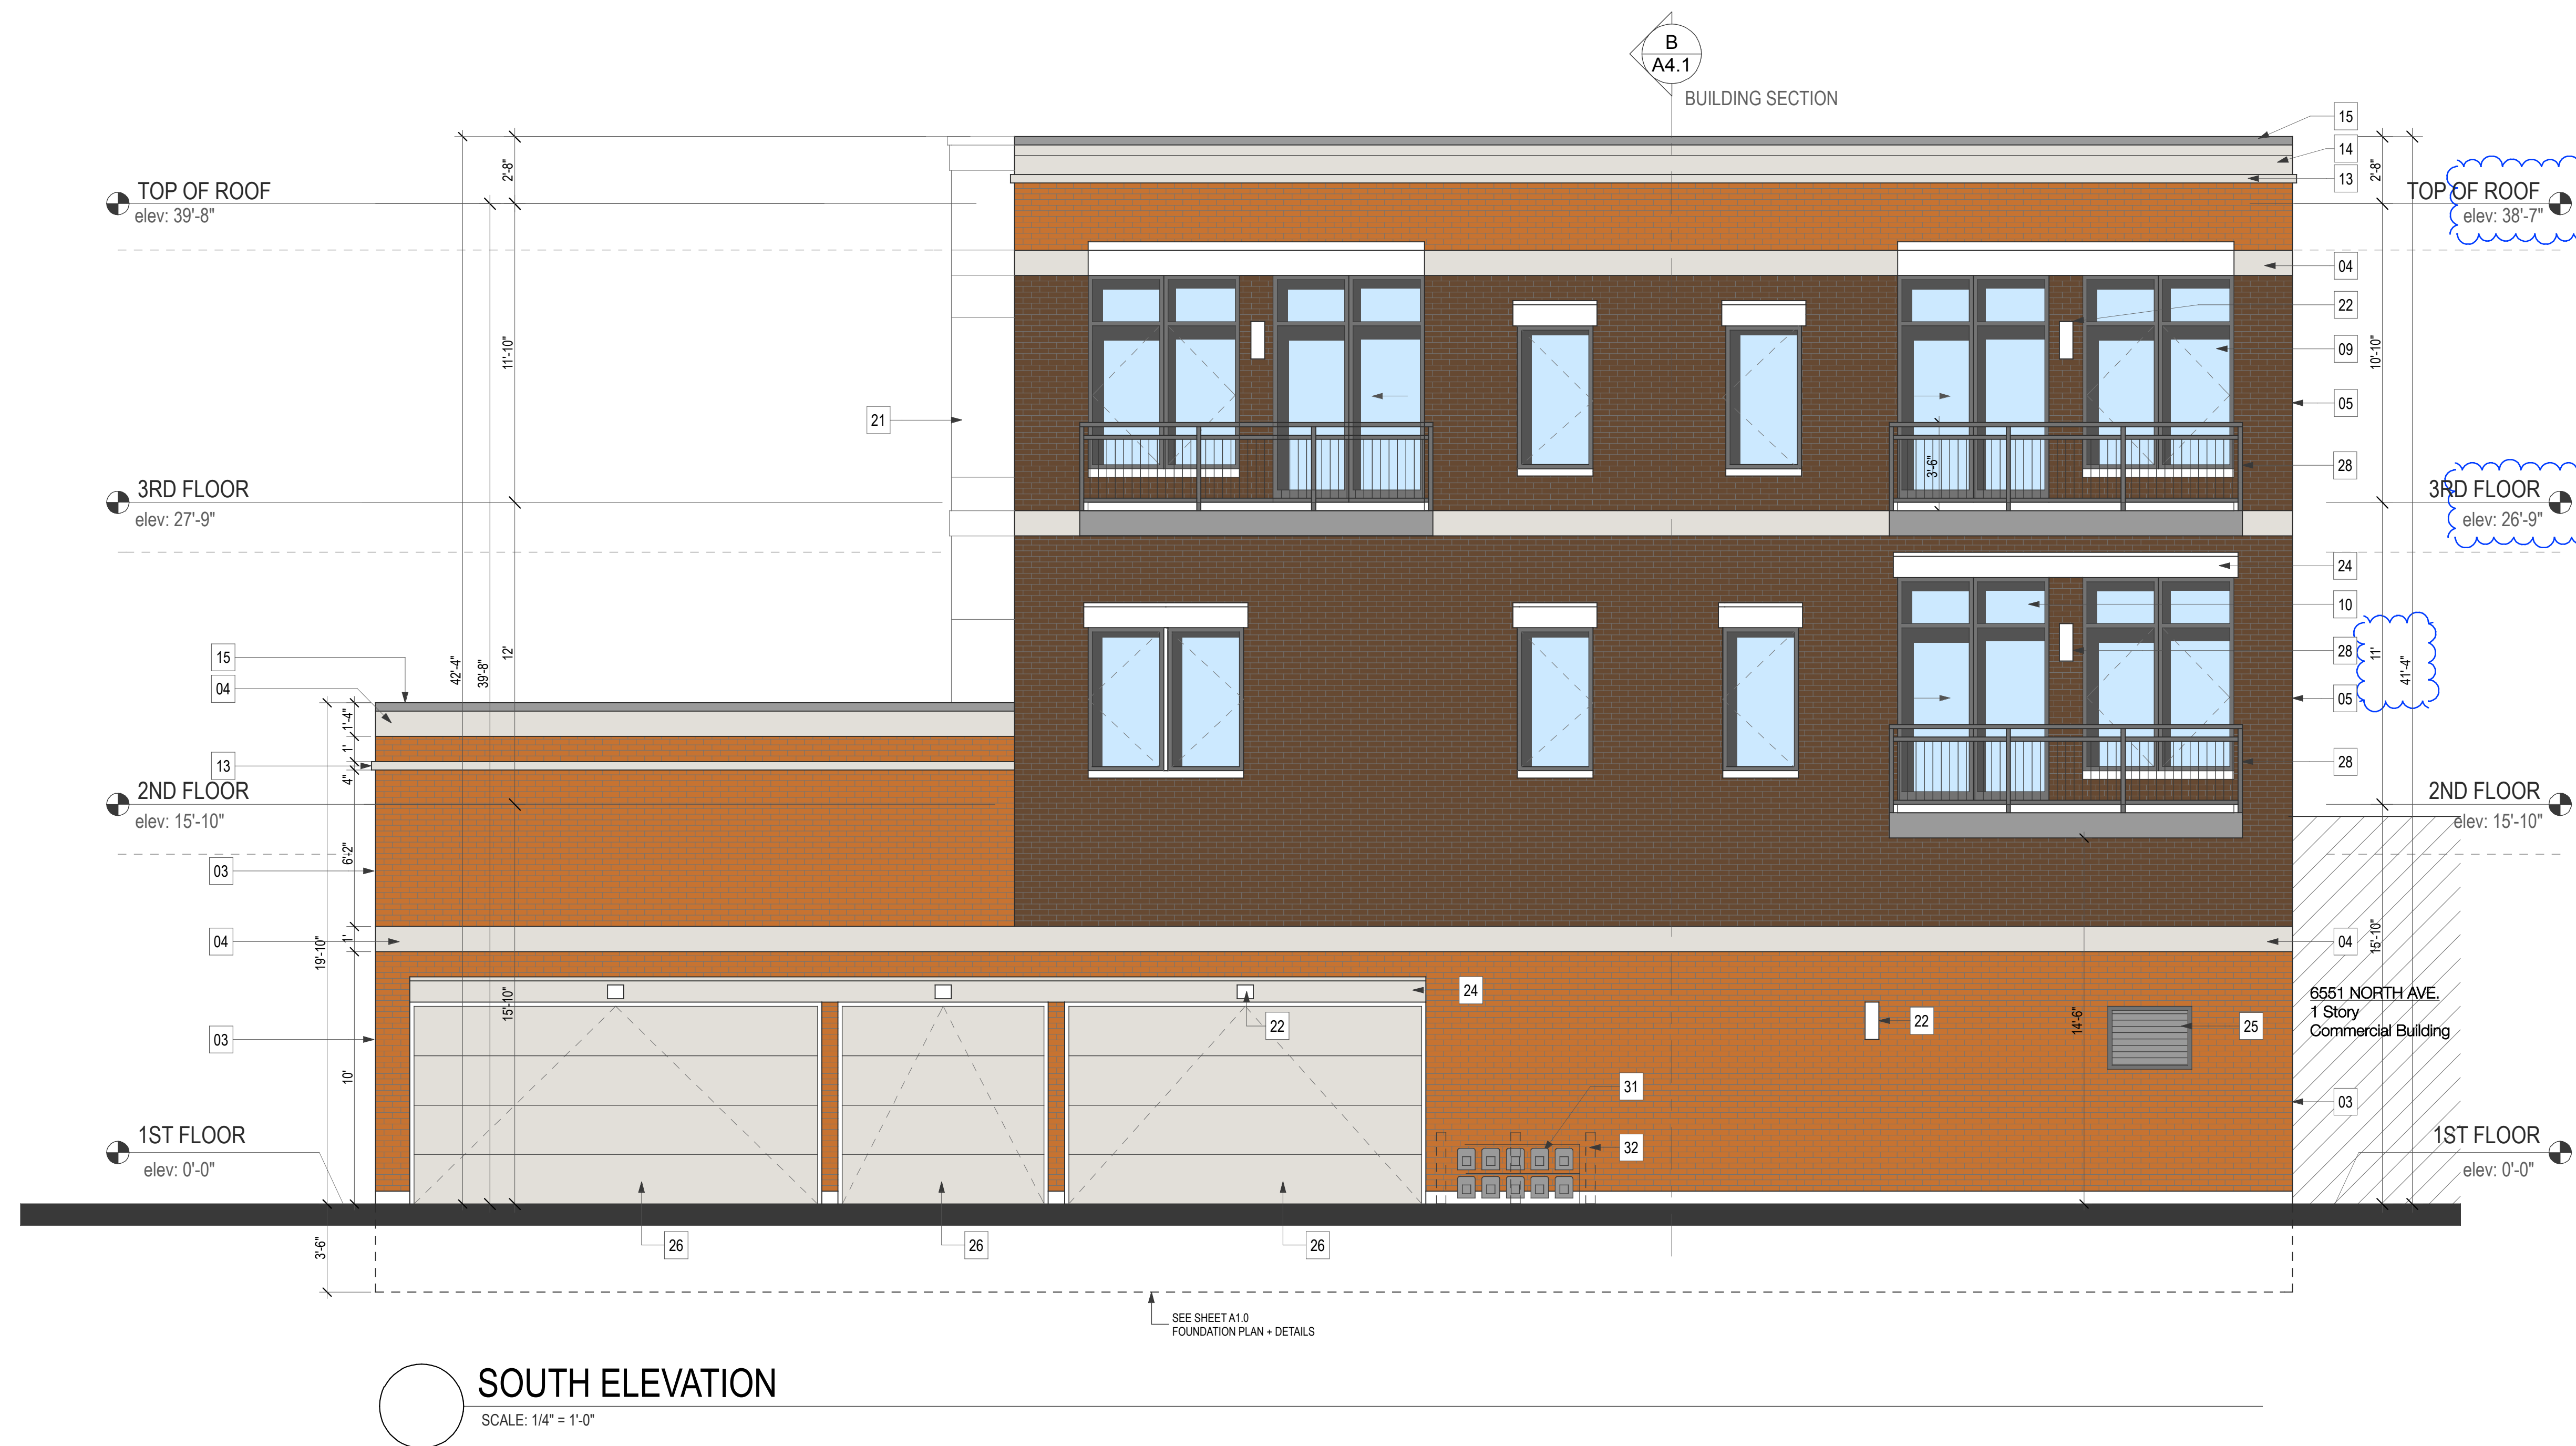

John Conrad Schiess

Architect+LEED AP

john@jcsarchitect.com

708 366 1500

office

400 Ashland Avenue
River Forest, Illinois 60305

studio

Oak Park, Illinois 60302


jcsarchitect.com

architecture +

John Conrad Schiess Architect, Ltd.

COPYRIGHT: John Conrad Schiess expressly reserves their common law copyright and other copyrights in these plans. These plans contain original material and ideas. These plans are not to be reproduced changed or copied in any form or manner whatsoever, nor are they to be assigned to any third party, without first obtaining the express written permission and consent of John Conrad Schiess.

I hereby certify that these plans were prepared under my direction and, to the best of my knowledge and belief, conform to the applicable Codes and Ordinances of the VILLAGE OF OAK PARK, Illinois.

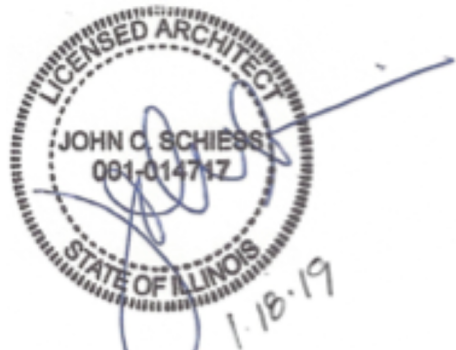

Expiration 11/30/20

Design Firm License No: 184.007511-0001

Project No: 03212017

JAN. 18, 2019, REV. BLDG. PERMIT

OCT. 1, 2018, BLDG. PERMIT + BID

AUG 23 2018 BID

Issued for

THE RESIDENCES at NORTHEAST OP

6553-6557
North Avenue
Oak Park, Illinois

Sheet Title
ELEVATIONS

A3.3

Sheet No.